

FLOOR PLAN
SCALE 1/4" = 1'-0"

DOOR SCHEDULE


QTY	SIZE	DESCRIPTION
1	8' X 7'	GARAGE DOOR
1	3'-0"	EXT LH
2	3'-0"	EXT RH
2	2'-8"	INT RH
2	1'-6"	INT RH
1	(2) 2'-0"	

WINDOW SCHEDULE

QTY	SIZE
2	3'X5'
1	3'X3'

- NOTES:**
1. ALL 8' PLATES EXCEPT WHERE OTHERWISE NOTED.
 2. SEE BUILDER ABOUT HVAC
 3. ALL WORK SUCH AS FRAMING, FOUNDATION, ELECTRICAL, PLUMBING, ETC., SHALL BE DONE ACCORDING TO LOCAL BUILDING CODES BEING ENFORCED.
 4. VERIFY ALL DIMENSIONS, NOTATIONS, AND DESIGN FOR ACCURACY BEFORE BEGINNING CONSTRUCTION.
 5. SEE BUILDER ABOUT ATTIC ACCESS LOCATION.


LIVING SQ. FT. - 576
NON LIVING SQ. FT. - 362
SLAB SQ. FT. - 938

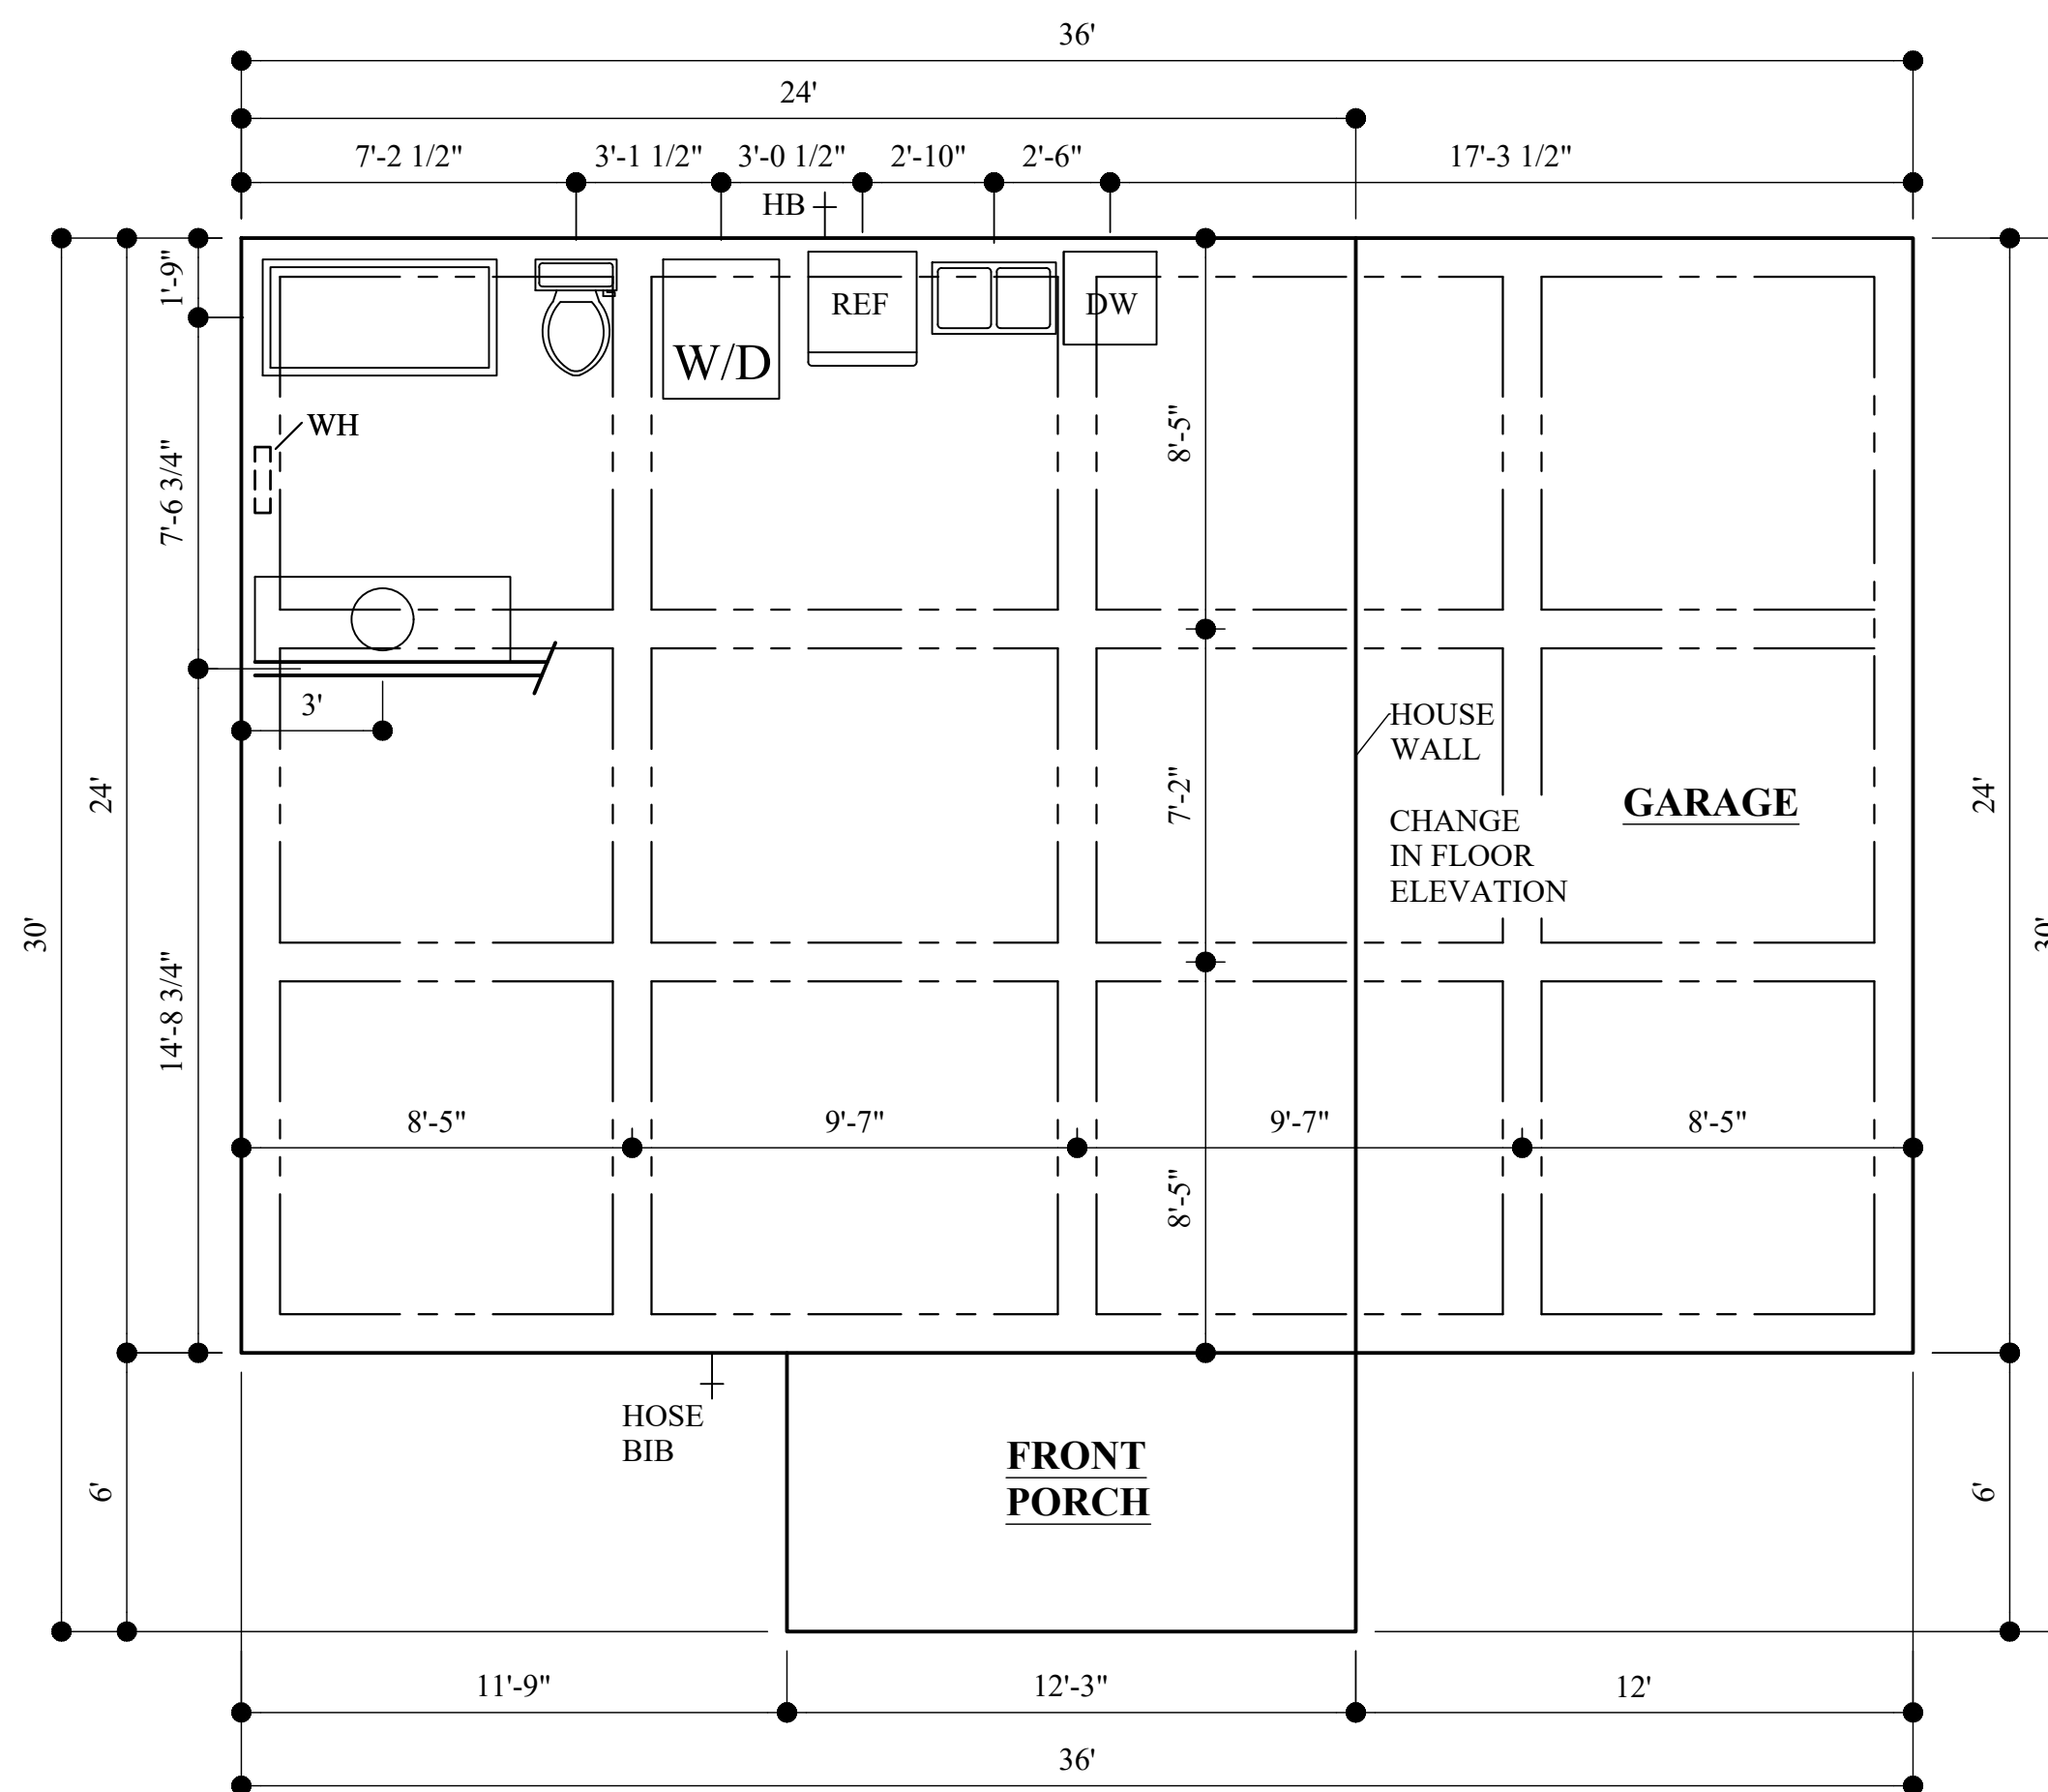


**FOUNDATION/
PLUMBING PLAN**
SCALE 1/4" = 1'-0"




FRONT ELEVATION
SCALE 1/8" = 1'-0"

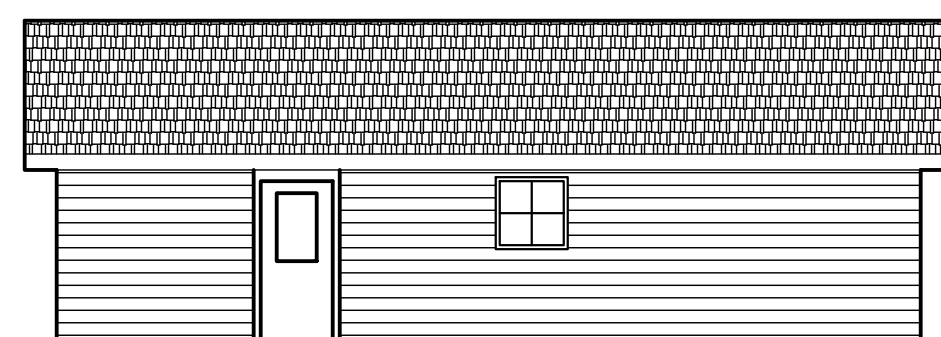

REAR ELEVATION
SCALE 1/8" = 1'-0"

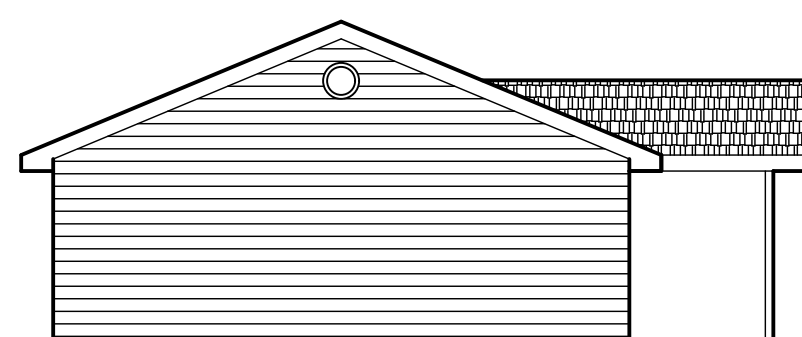

LEFT ELEVATION
SCALE 1/8" = 1'-0"

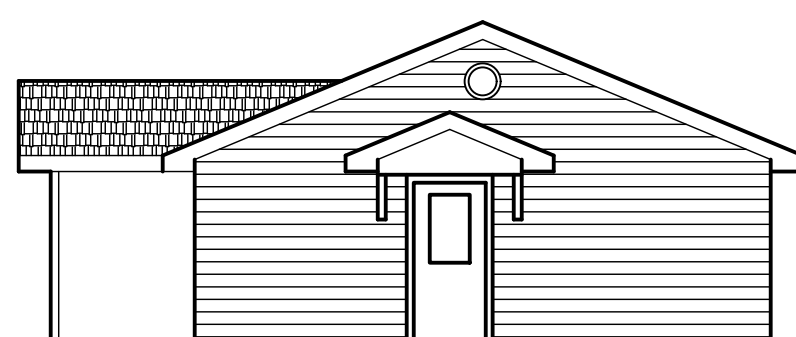

RIGHT ELEVATION
SCALE 1/8" = 1'-0"


Need Help?
Plan # Item #

AFFORDABLE CITY HOMES


Email:
Help@AffordableCityHomes.com

1. Grading/Grounds
2. Termite Treatment
3. Foundation/Concrete
4. Framing
5. Roof Shingles
6. Windows Install
7. Siding Install
8. Doors exterior
9. Rough Electrical
10. Rough Plumbing
11. Rough HVAC
12. Insulation
13. Sheetrock Install
14. Sheetrock tape/bed
15. Doors interior
16. Painting int/exterior
17. Light fixtures
18. Flooring
19. Finish Electrical
20. Finish Plumbing
21. Finish HVAC
22. Appliances
23. Sinks
24. Cabinets
25. Trim Work
26. Sod
27. Fence
28. Finish Inside/Outside

Information From Reliable Sources
BUT We Make NO Guarantee.

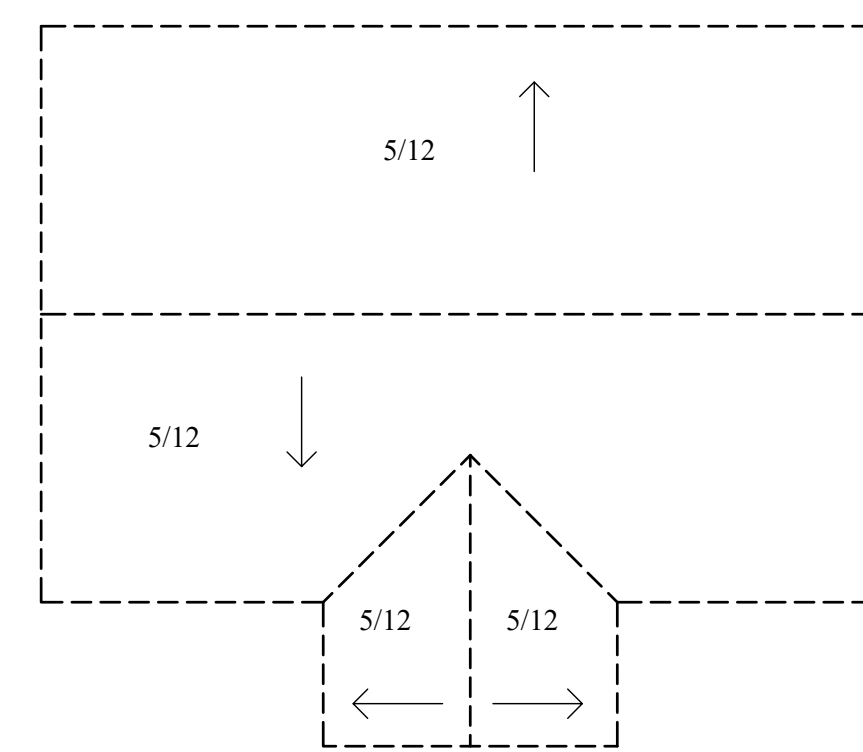

ROOF PLAN
SCALE 1/8" = 1'-0"

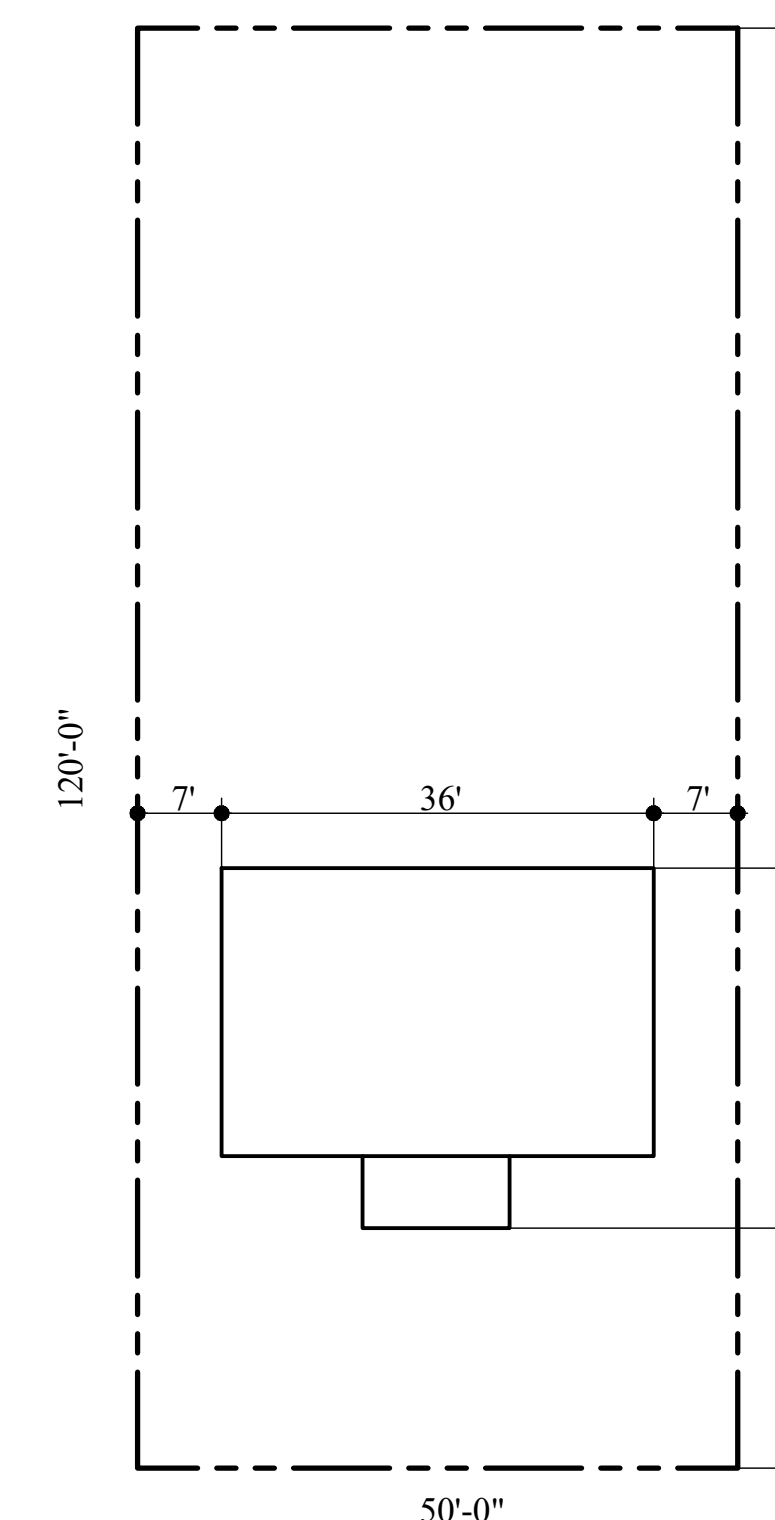

PLOT PLAN
SCALE 1/16" = 1'-0"

FLOOR, FOUNDATION, ELEVATION,
ELECTRICAL, PLUMBING, PLOT, ROOF PLAN

1 BEDRM - 24'X24' + GARAGE

PLAN B

AffordableCityHomes.com