

**FLOOR PLAN**  
SCALE 1/4" = 1'-0"

**DOOR SCHEDULE**


QTY	SIZE	DESCRIPTION
2	3'-0"	EXT LH
2	2'-8"	INT RH
1	2'-0"	INT RH
1	1'-6"	INT RH
1	(2) 3'-0"	INT
1	(2) 2'-0"	INT

**WINDOW SCHEDULE**

QTY	SIZE
3	3'X5'
1	3'X3'

- NOTES:**
1. ALL 8' PLATES EXCEPT WHERE OTHERWISE NOTED.
  2. SEE BUILDER ABOUT HVAC.
  3. ALL WORK SUCH AS FRAMING, FOUNDATION, ELECTRICAL, PLUMBING, ETC... SHALL BE DONE ACCORDING TO LOCAL BUILDING CODES BEING ENFORCED.
  4. VERIFY ALL DIMENSIONS, NOTATIONS, AND DESIGN FOR ACCURACY BEFORE BEGINNING CONSTRUCTION.
  5. SEE BUILDER ABOUT ATTIC ACCESS LOCATION.

LIVING SQ. FT. - 988  
PORCHES - 110  
SLAB SQ. FT. - 1,098

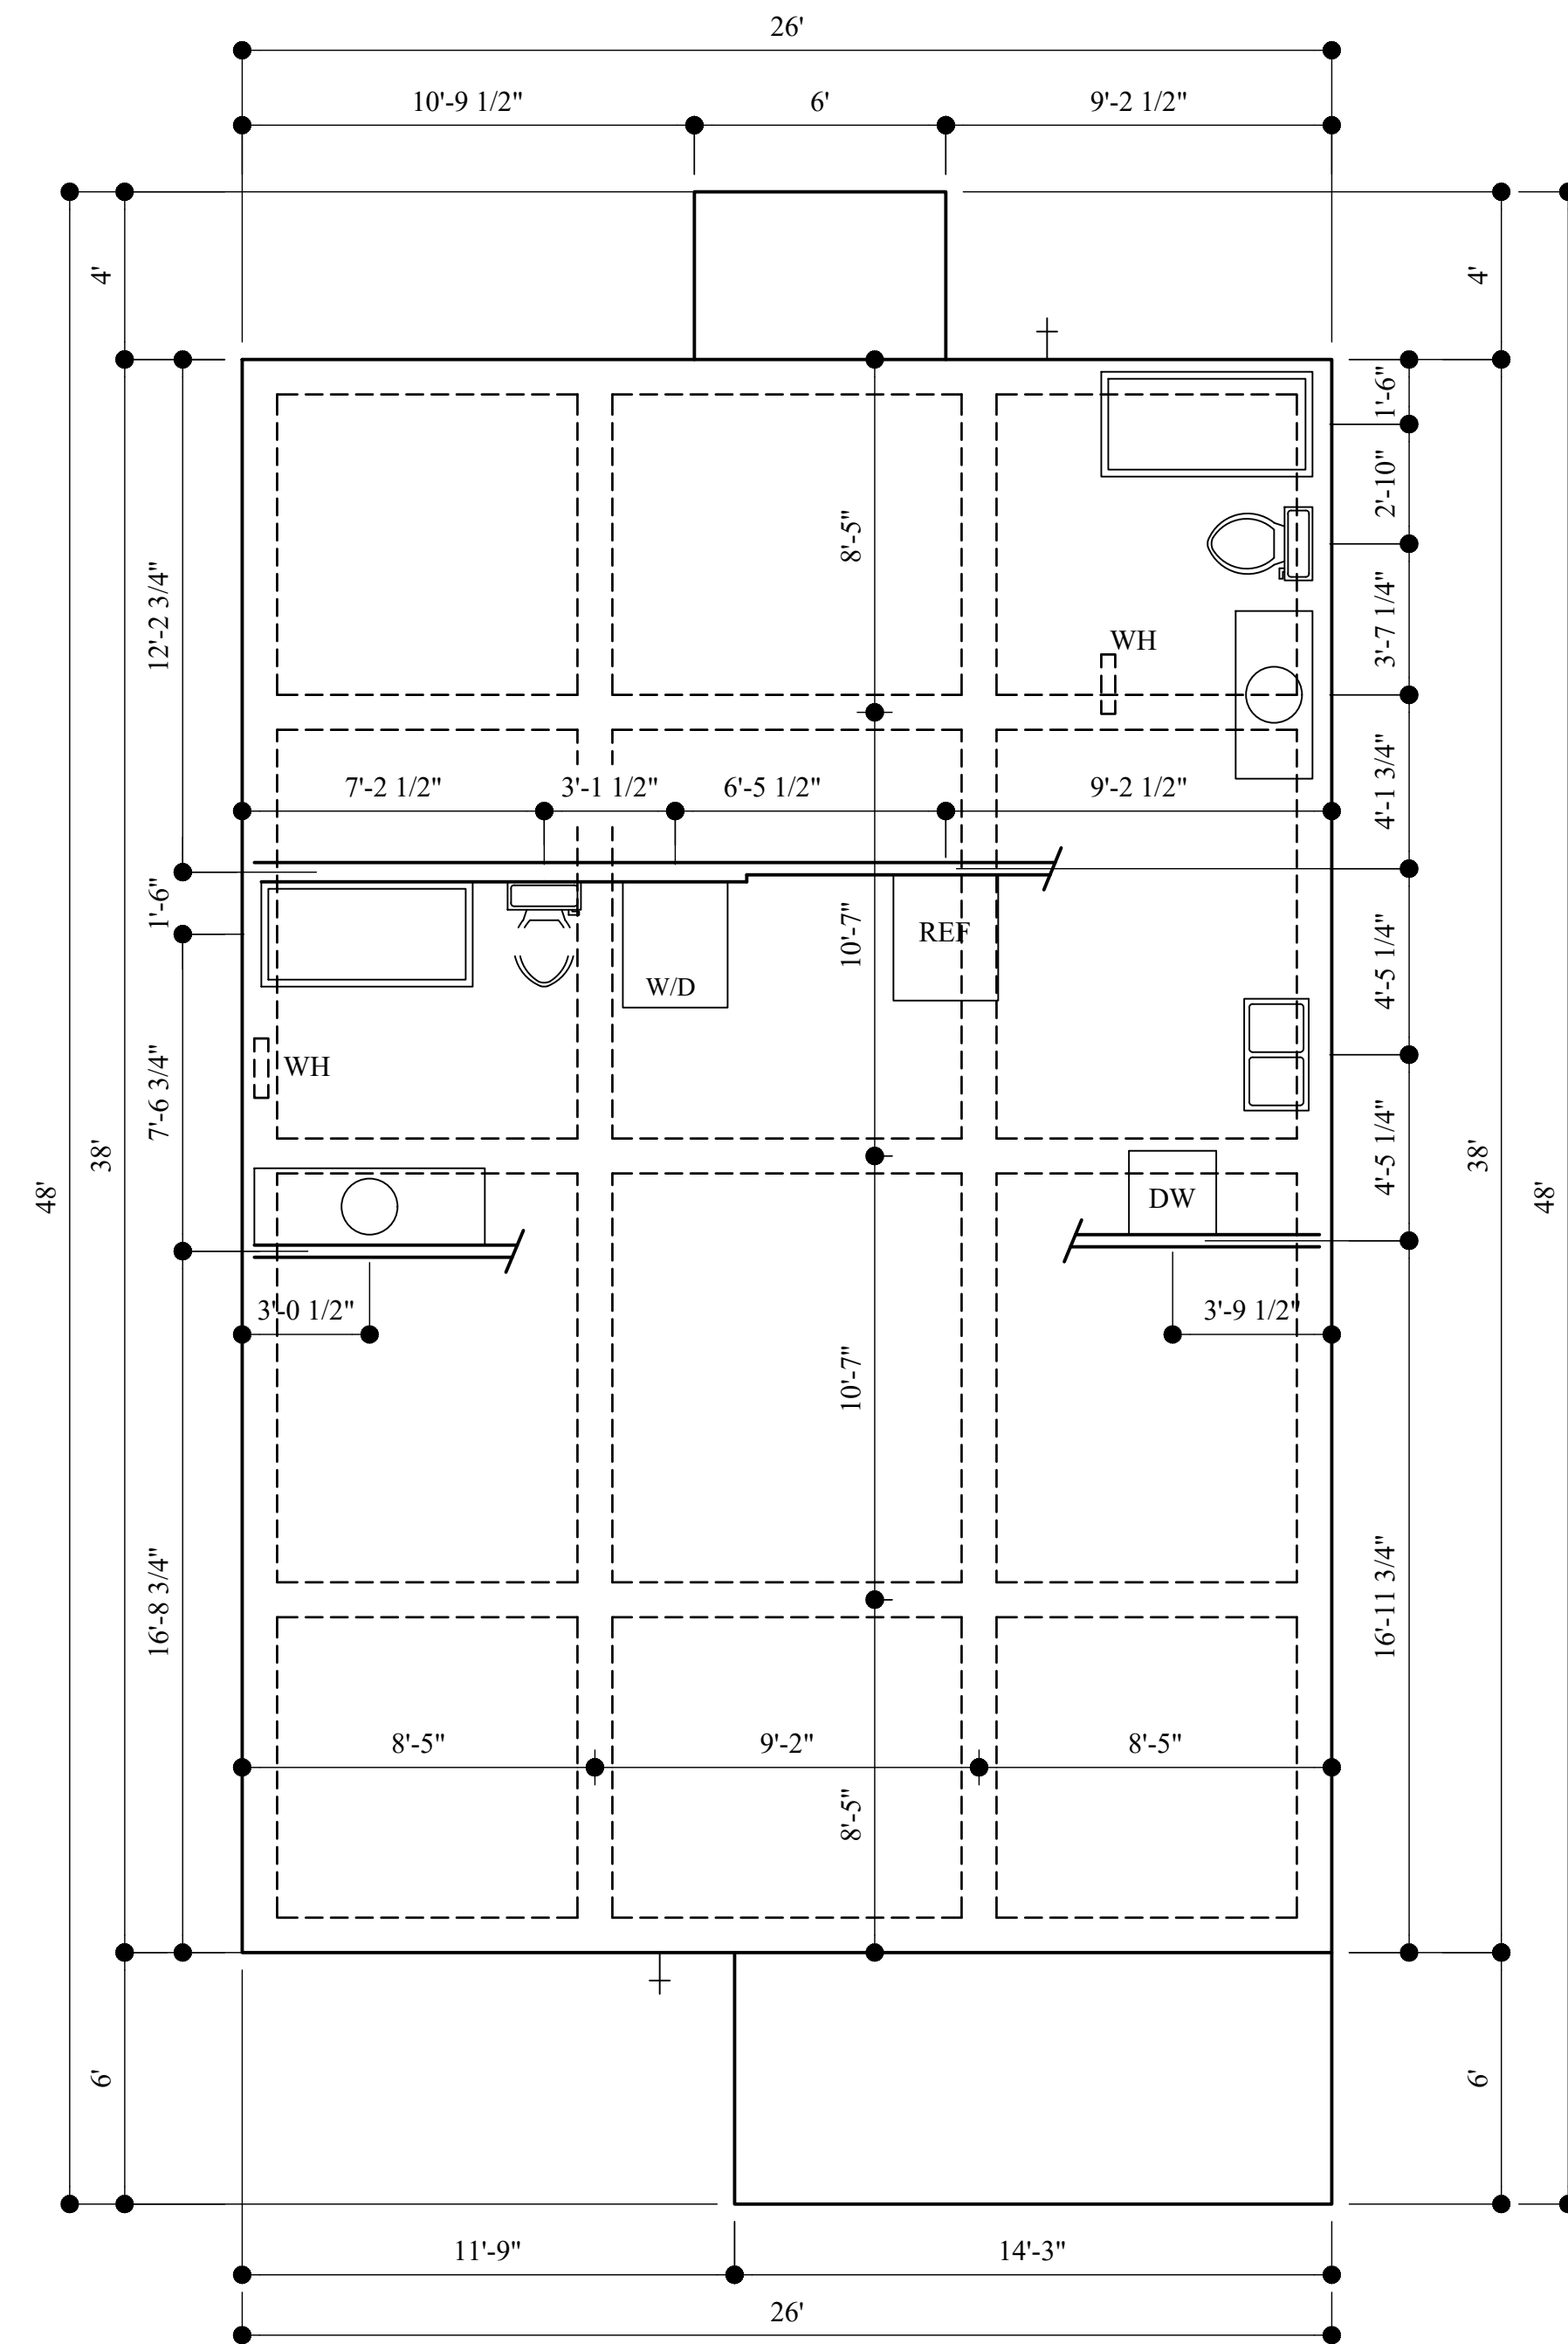


**FOUNDATION/  
PLUMBING PLAN**  
SCALE 1/4" = 1'-0"




**FRONT ELEVATION**  
SCALE 1/8" = 1'-0"



**REAR ELEVATION**  
SCALE 1/8" = 1'-0"

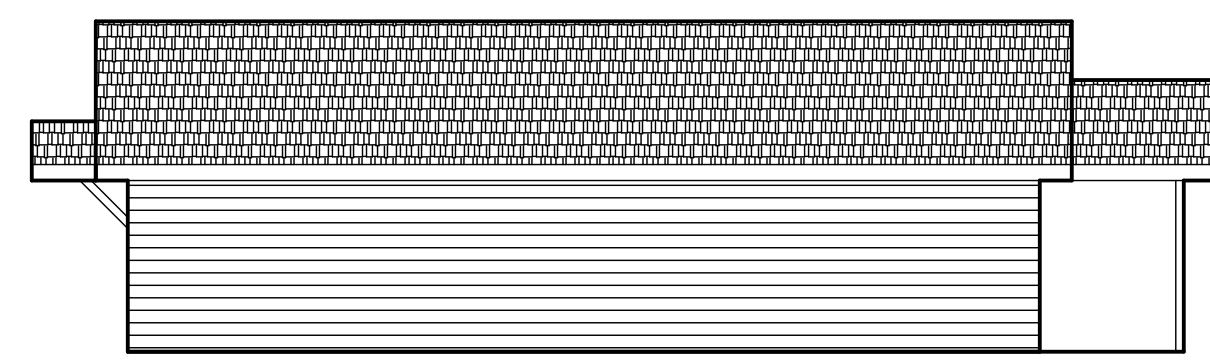

**LEFT ELEVATION**  
SCALE 1/8" = 1'-0"

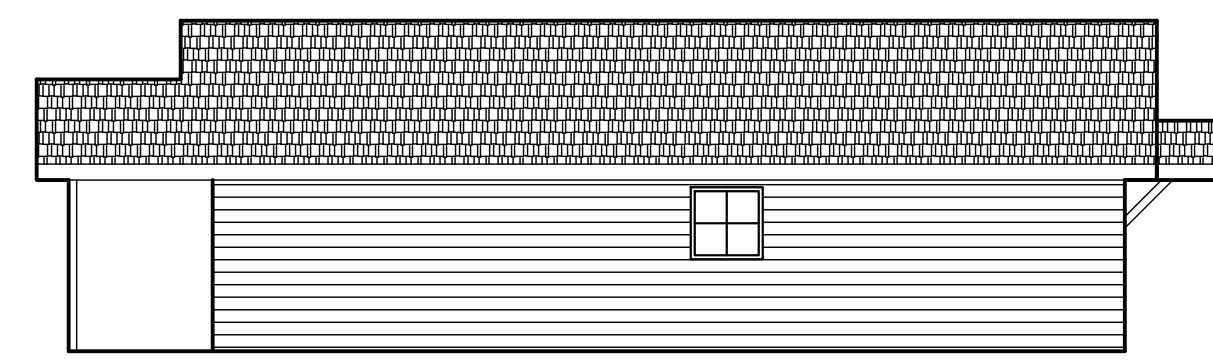


**RIGHT ELEVATION**  
SCALE 1/8" = 1'-0"

**Need Help?**  
Plan # Item #


Email:  
Help@AffordableCityHomes.com

1. Grading/Grounds
2. Termite Treatment
3. Foundation/Concrete
4. Framing
5. Roof Shingles
6. Windows Install
7. Siding Install
8. Doors exterior
9. Rough Electrical
10. Rough Plumbing
11. Rough HVAC
12. Insulation
13. Sheetrock Install
14. Sheetrock tape/bed
15. Doors interior
16. Painting int/exterior
17. Light fixtures
18. Flooring
19. Finish Electrical
20. Finish Plumbing
21. Finish HVAC
22. Appliances
23. Sinks
24. Cabinets
25. Trim Work
26. Sod
27. Fence
28. Finish Inside/Outside

Information From Reliable Sources  
BUT We Make NO Guarantee.

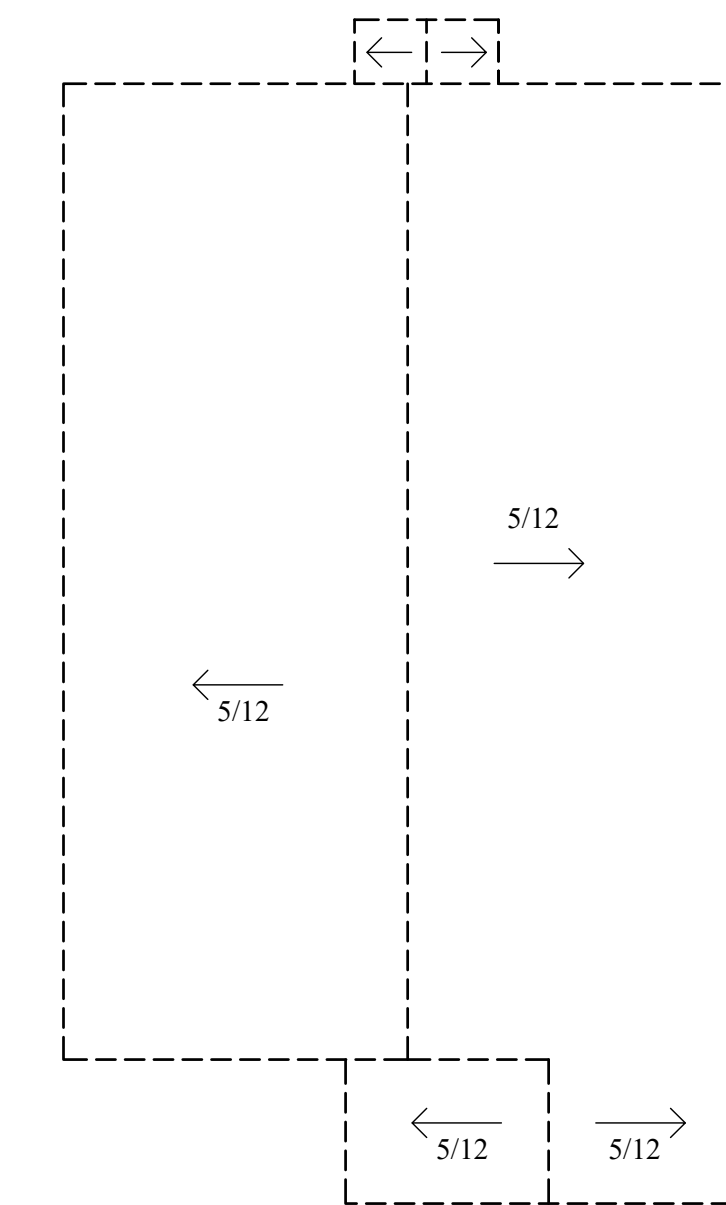

**ROOF PLAN**  
SCALE 1/8" = 1'-0"

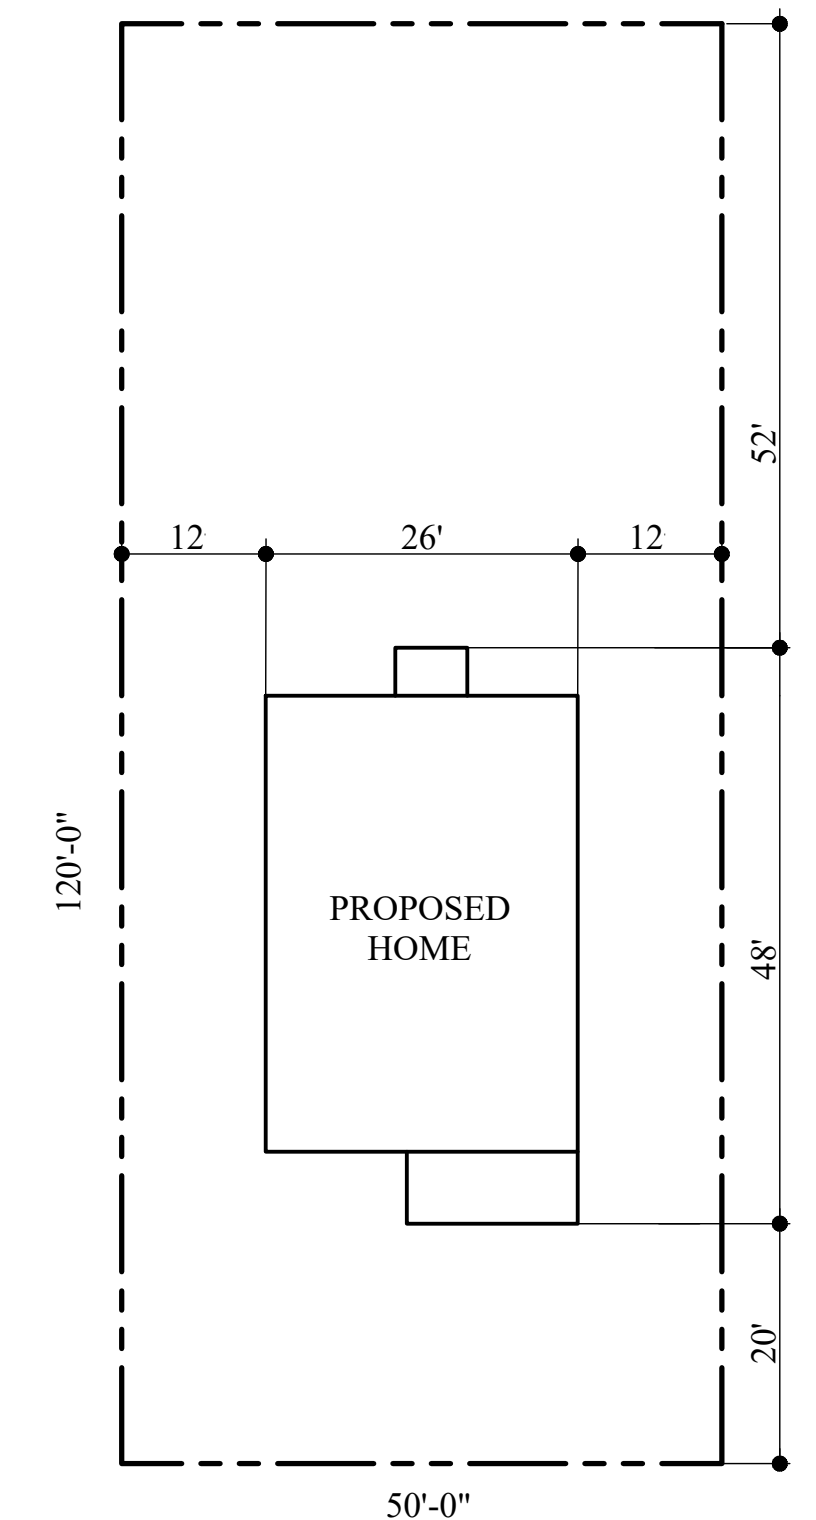

**PLOT PLAN**  
SCALE 1/16" = 1'-0"