

FLOOR PLAN
SCALE 1/4" = 1'-0"

DOOR SCHEDULE

 
QTY	SIZE	DESCRIPTION
2	3'-0"	EXT LH
1	3'-0"	EXT RH
2	2'-8"	INT RH
2	2'-8"	INT LH
3	2'-0"	INT RH
3	2'-0"	INT LH
2	1'-6"	INT RH
1	(2) 2'-0"	INT

WINDOW SCHEDULE


QTY	SIZE
4	3'X5'
1	3'X3'

- NOTES:**
- ALL 8" PLATES EXCEPT WHERE OTHERWISE NOTED.
 - SEE BUILDER ABOUT HVAC.
 - ALL WORK SUCH AS FRAMING, FOUNDATION, ELECTRICAL, PLUMBING, ETC., SHALL BE DONE ACCORDING TO LOCAL BUILDING CODES BEING ENFORCED.
 - VERIFY ALL DIMENSIONS, NOTATIONS, AND DESIGN FOR ACCURACY BEFORE BEGINNING CONSTRUCTION.
 - SEE BUILDER ABOUT ATTIC ACCESS LOCATION.

SYMBOLS:
FIRE WALL - BUILD ACCORDING TO CODE




LIVING SQ. FT. - 1444
PORCHES - 126
SLAB SQ. FT. - 1,570

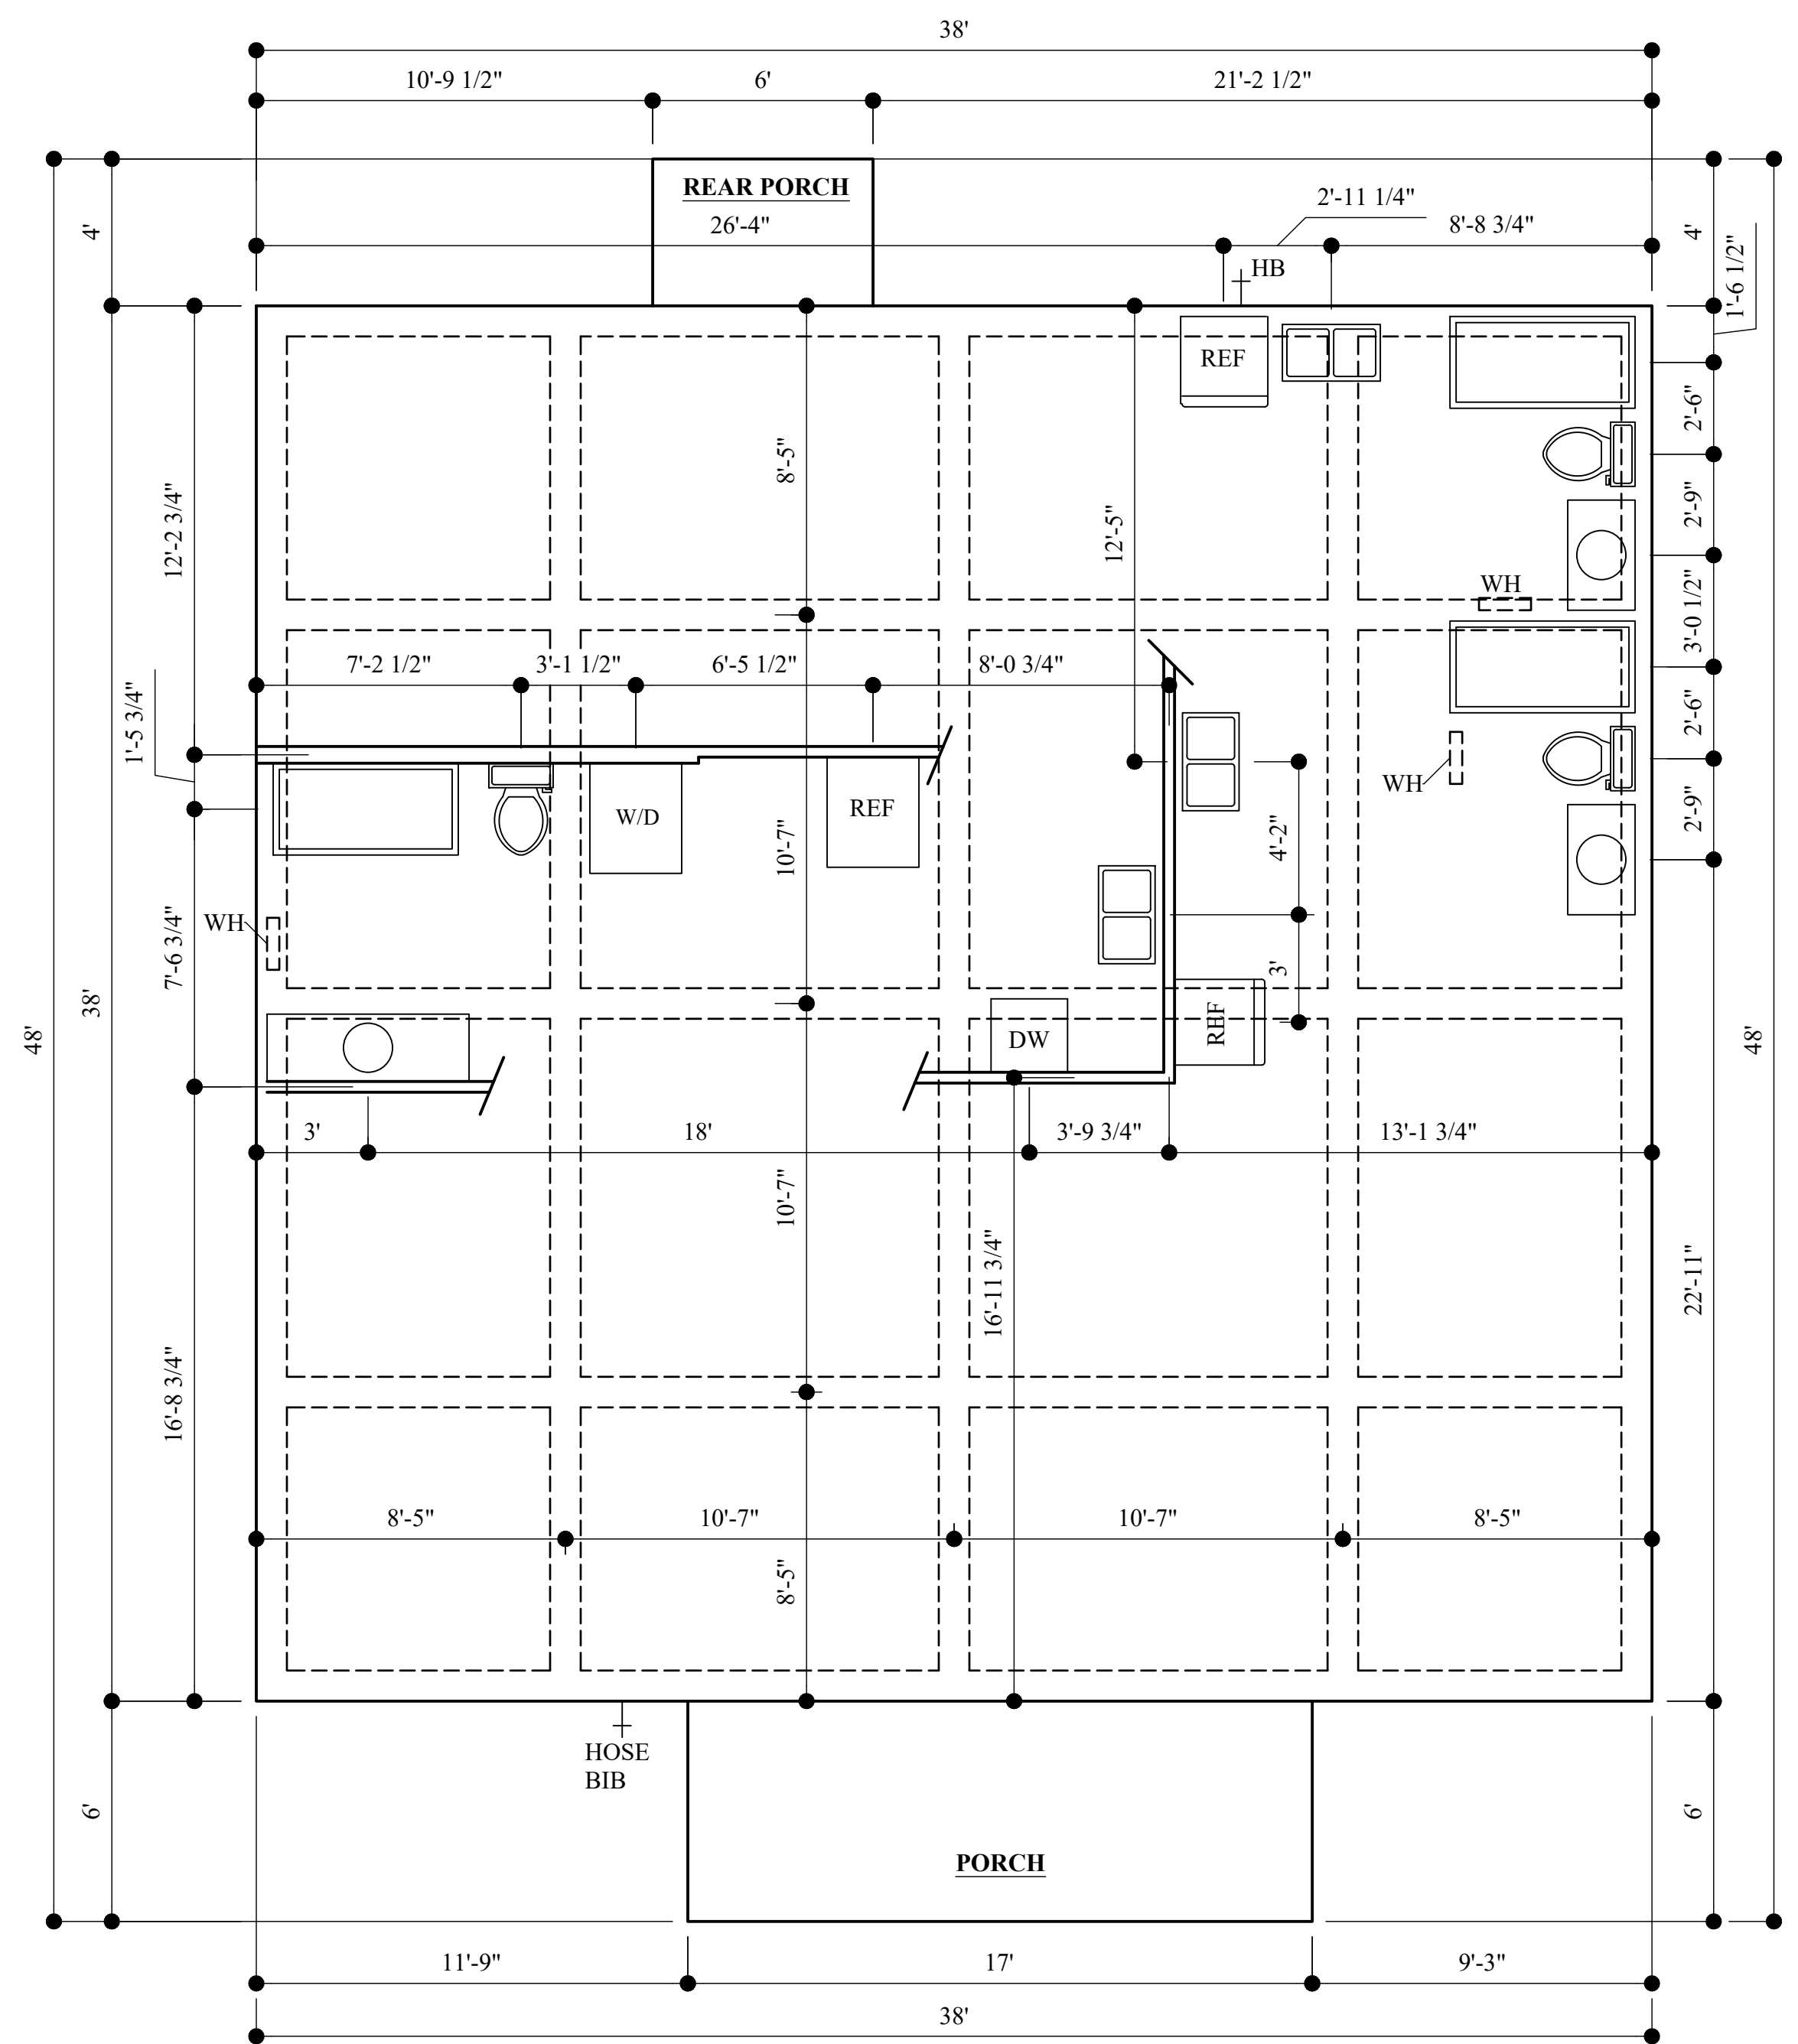


**FOUNDATION/
PLUMBING PLAN**
SCALE 1/4" = 1'-0"




FRONT ELEVATION
SCALE 1/8" = 1'-0"

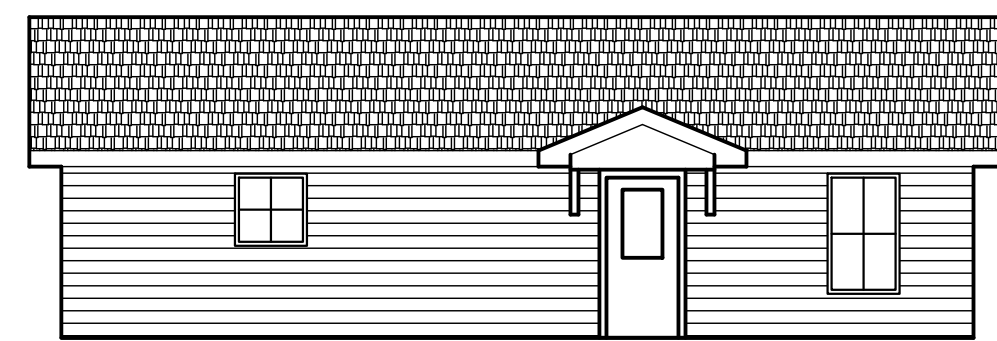

REAR ELEVATION
SCALE 1/8" = 1'-0"

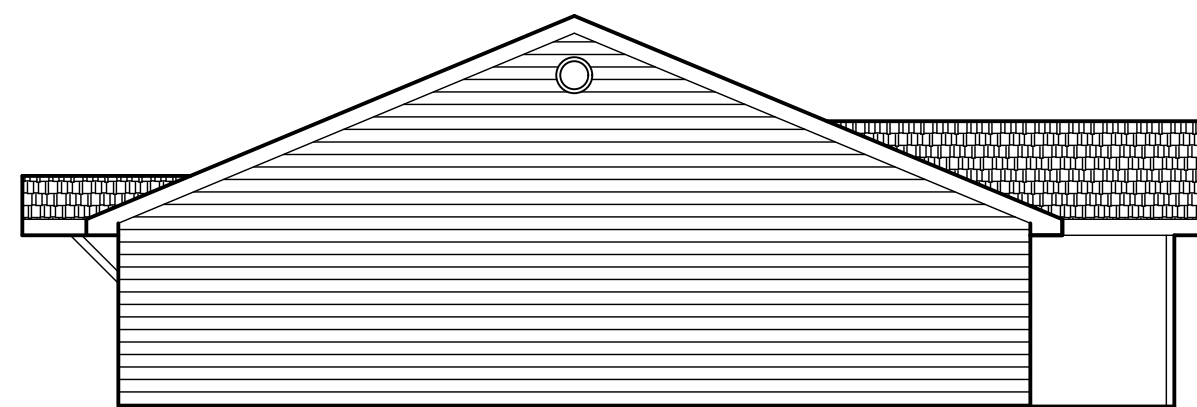

LEFT ELEVATION
SCALE 1/8" = 1'-0"

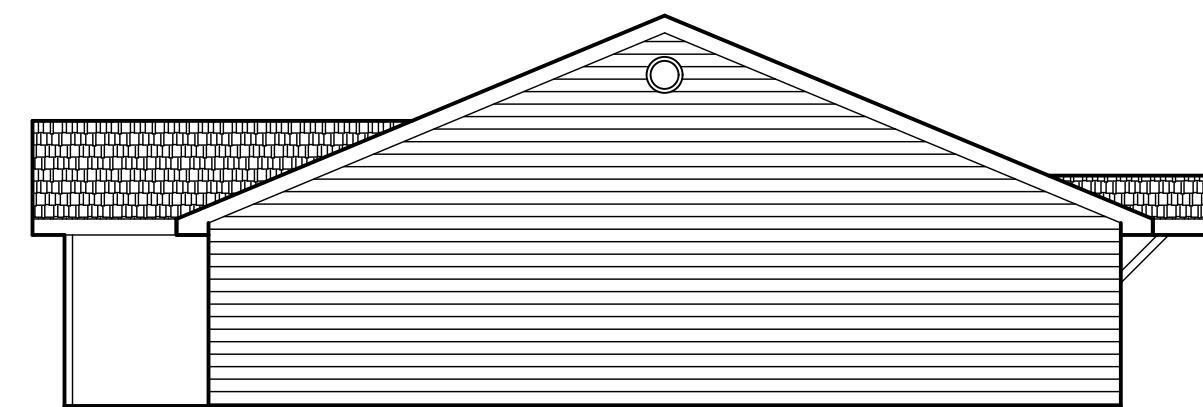

RIGHT ELEVATION
SCALE 1/8" = 1'-0"


Need Help?
Plan # Item #

AFFORDABLE CITY HOMES


Email:
Help@AffordableCityHomes.com

- Grading/Grounds
- Termite Treatment
- Foundation/Concrete
- Framing
- Roof Shingles
- Windows Install
- Siding Install
- Doors exterior
- Rough Electrical
- Rough Plumbing
- Rough HVAC
- Insulation
- Sheetrock Install
- Sheetrock tape/bed
- Doors interior
- Painting int/exterior
- Light fixtures
- Flooring
- Finish Electrical
- Finish Plumbing
- Finish HVAC
- Appliances
- Sinks
- Cabinets
- Trim Work
- Sod
- Fence
- Finish Inside/Outside

Information From Reliable Sources
BUT We Make NO Guarantee.

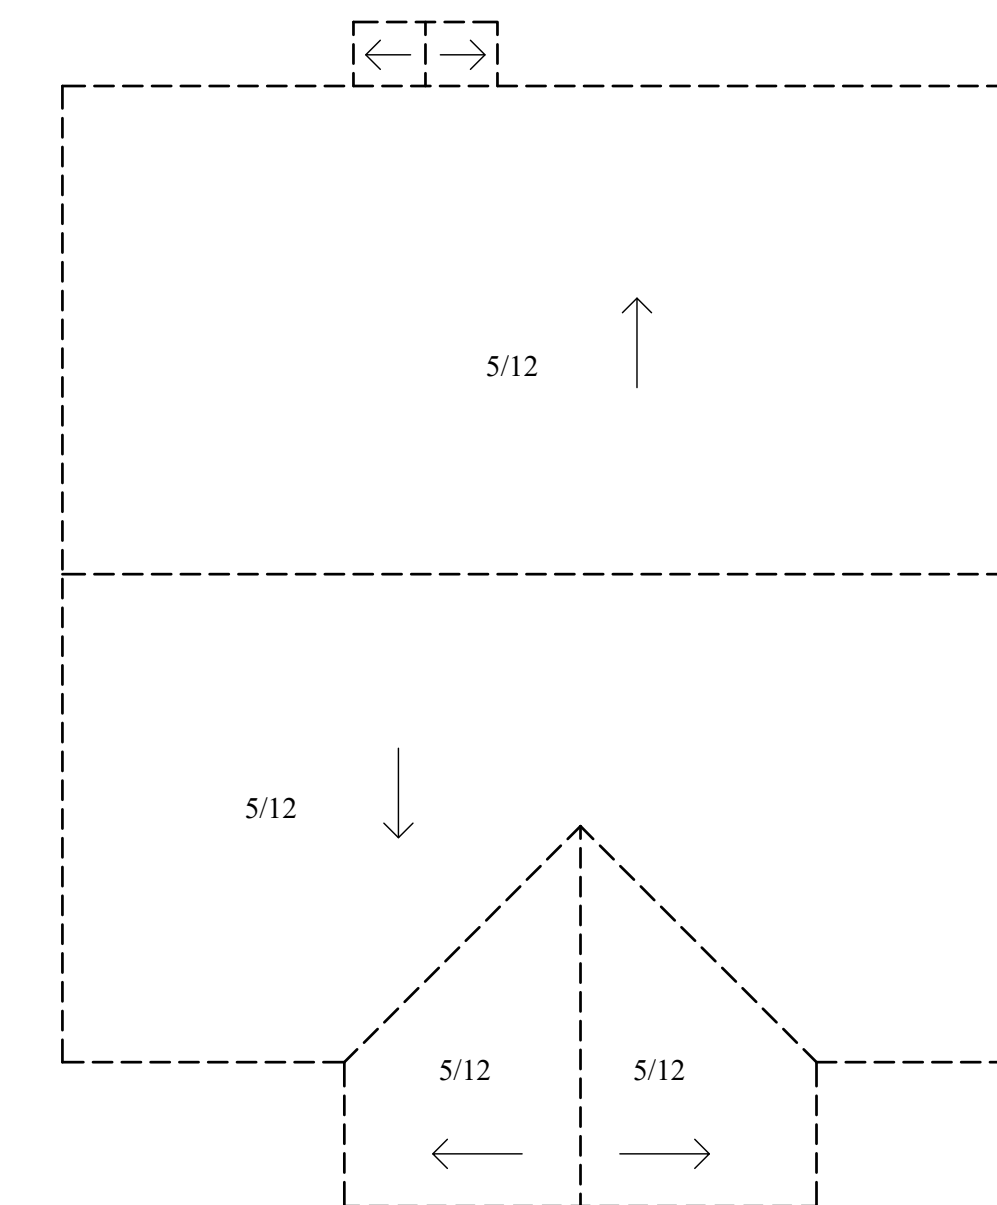

ROOF PLAN
SCALE 1/8" = 1'-0"

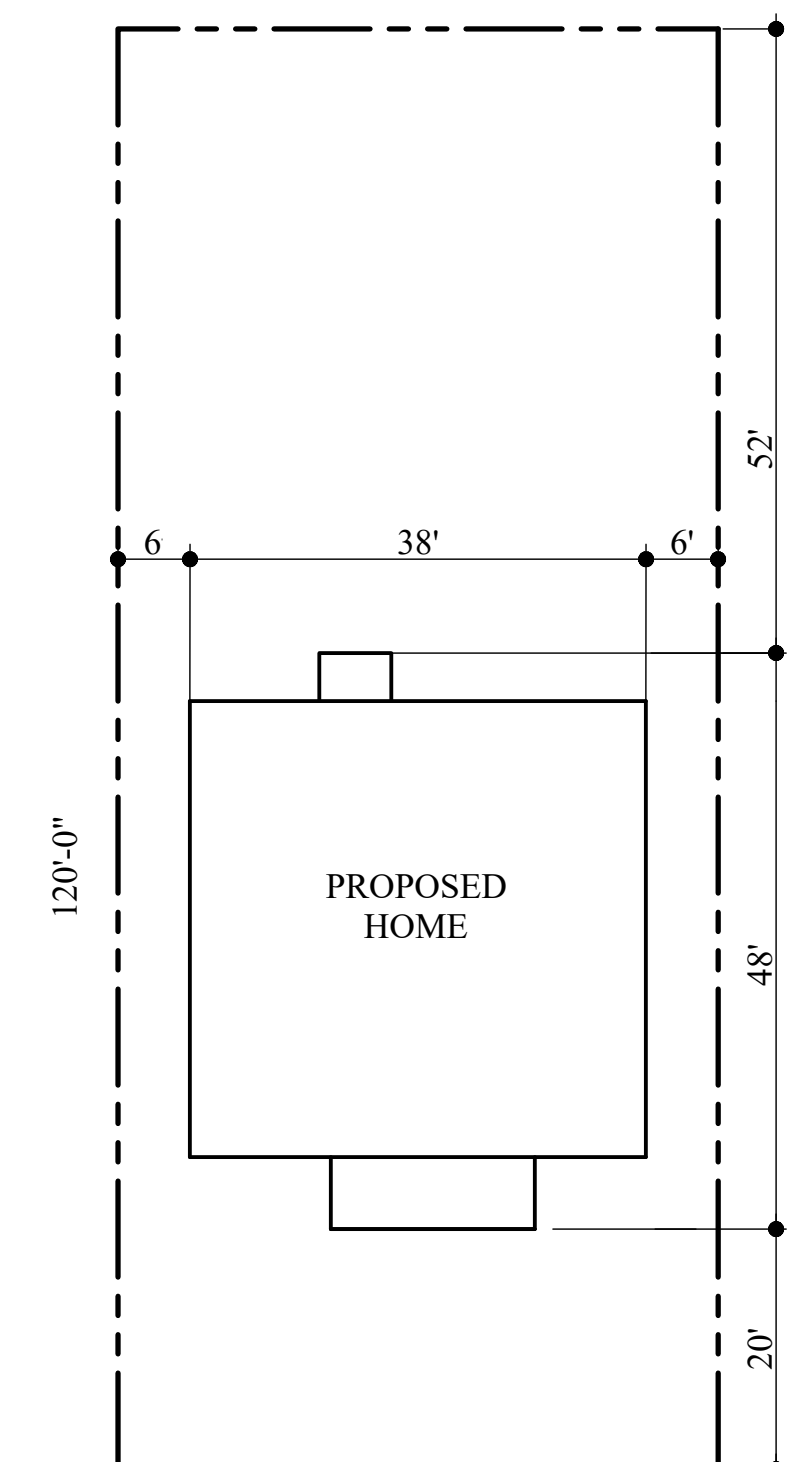

PLOT PLAN
SCALE 1/16" = 1'-0"

FLOOR, FOUNDATION, ELEVATION,
ELECTRICAL, PLUMBING, PLOT, ROOF PLAN

3 BEDRM - 38'X38'

PLAN P

AffordableCityHomes.com